




SECTION A-A

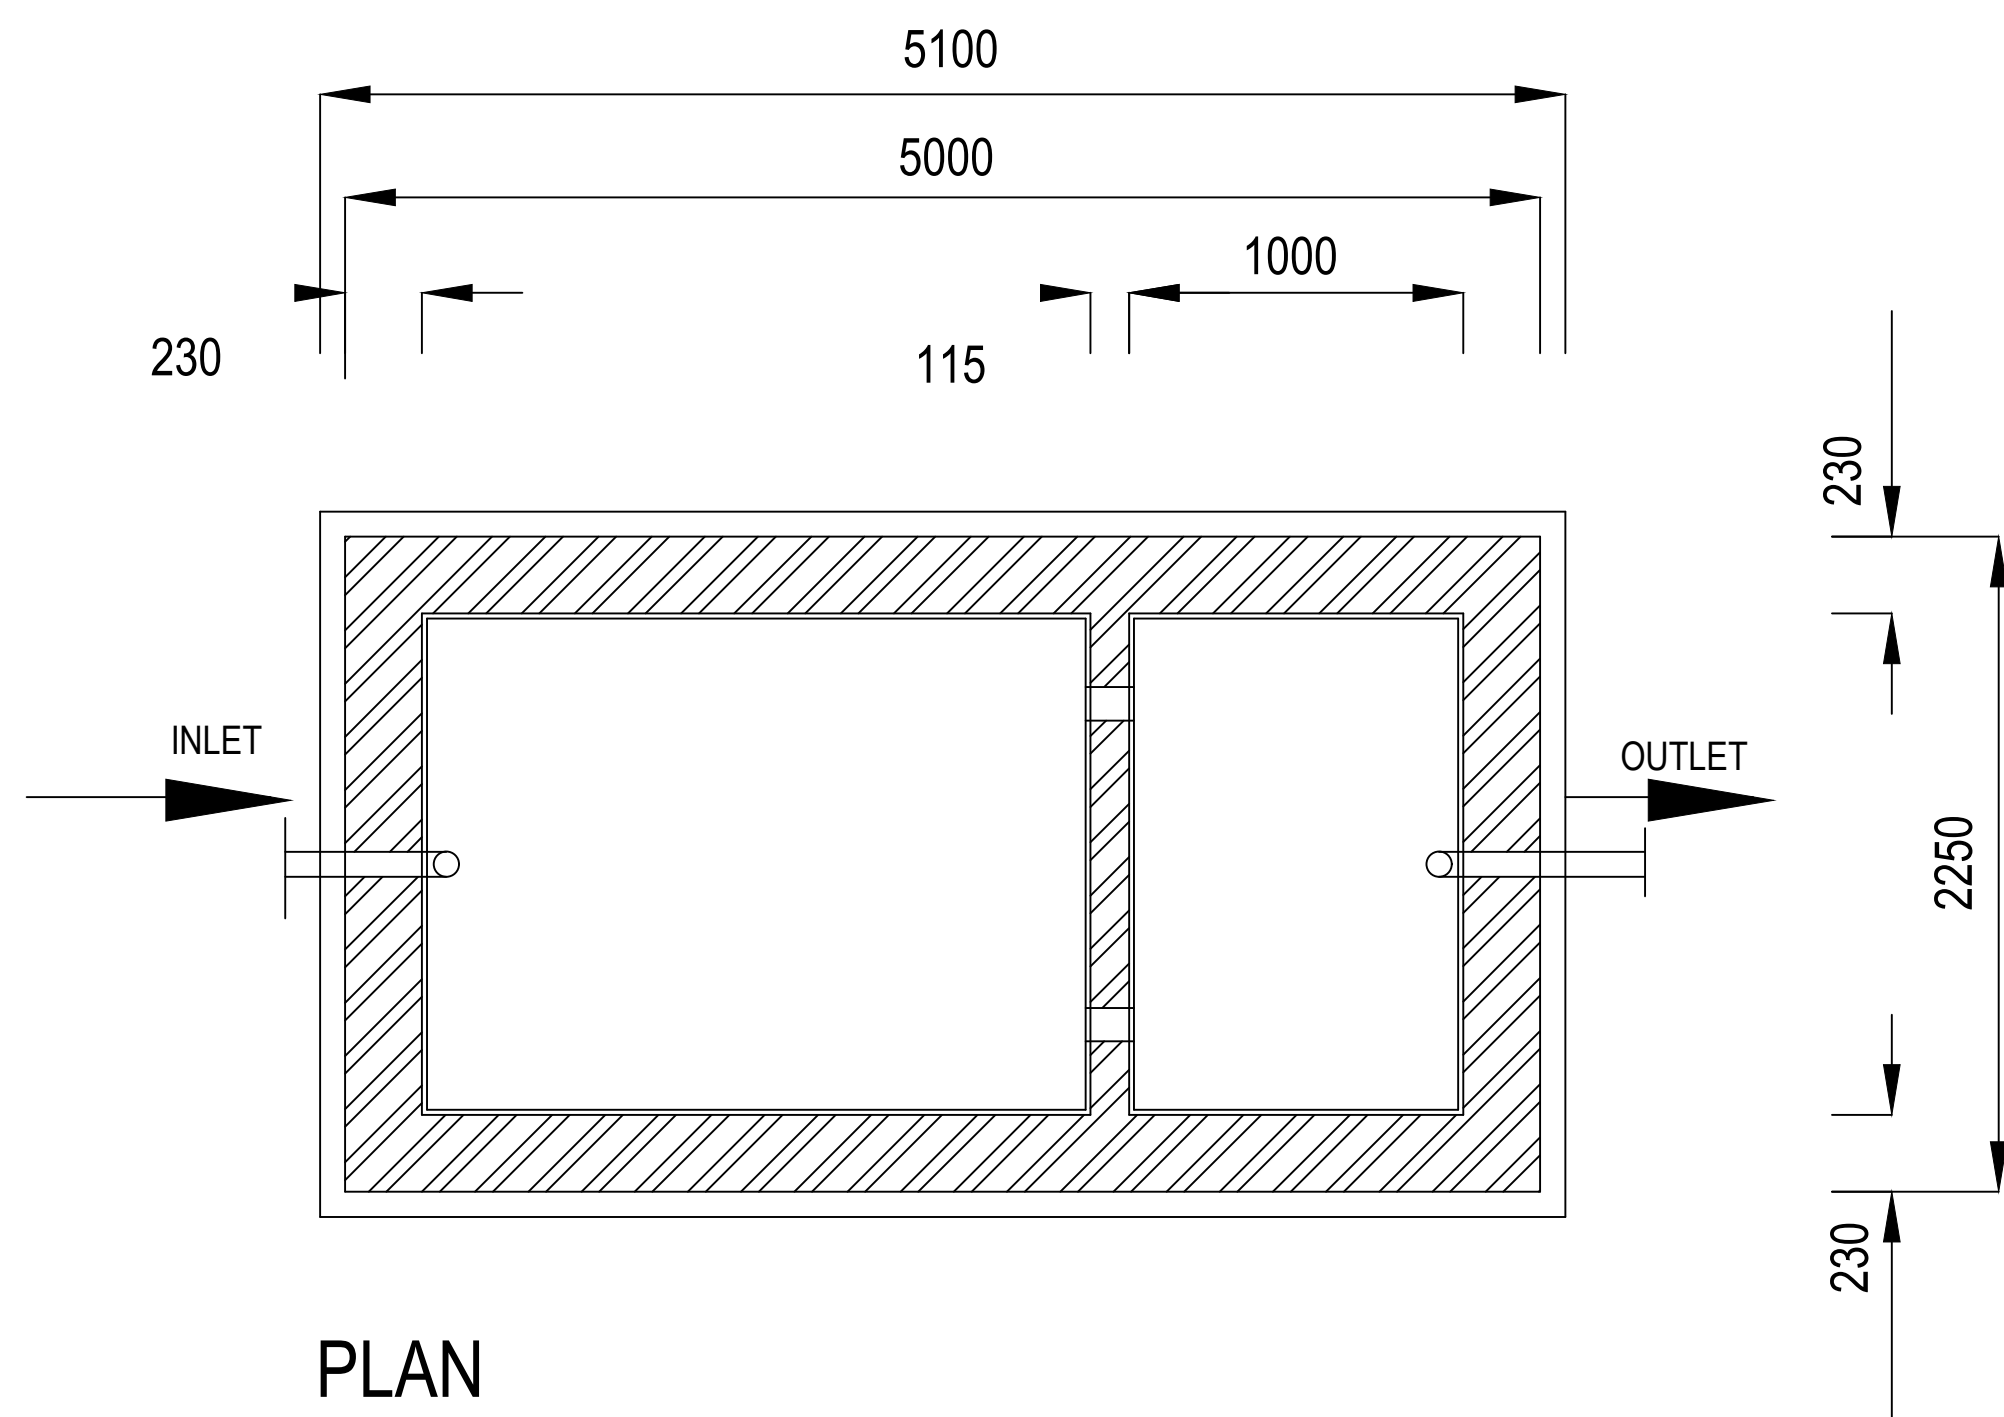

PLAN

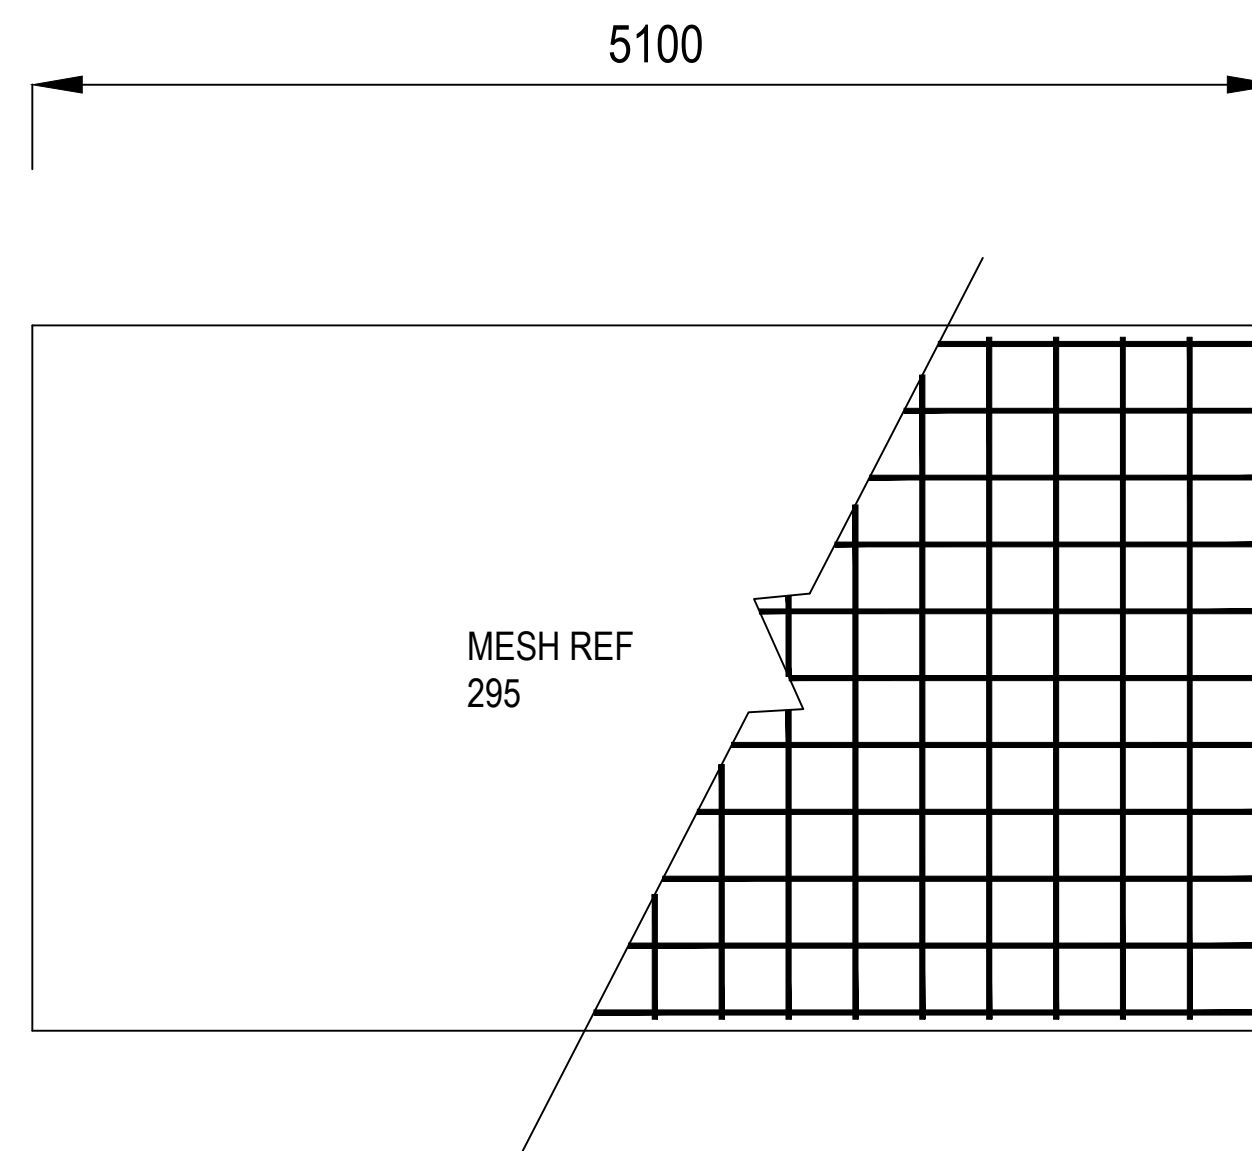

FLOOR SLAB REINFORCEMENT

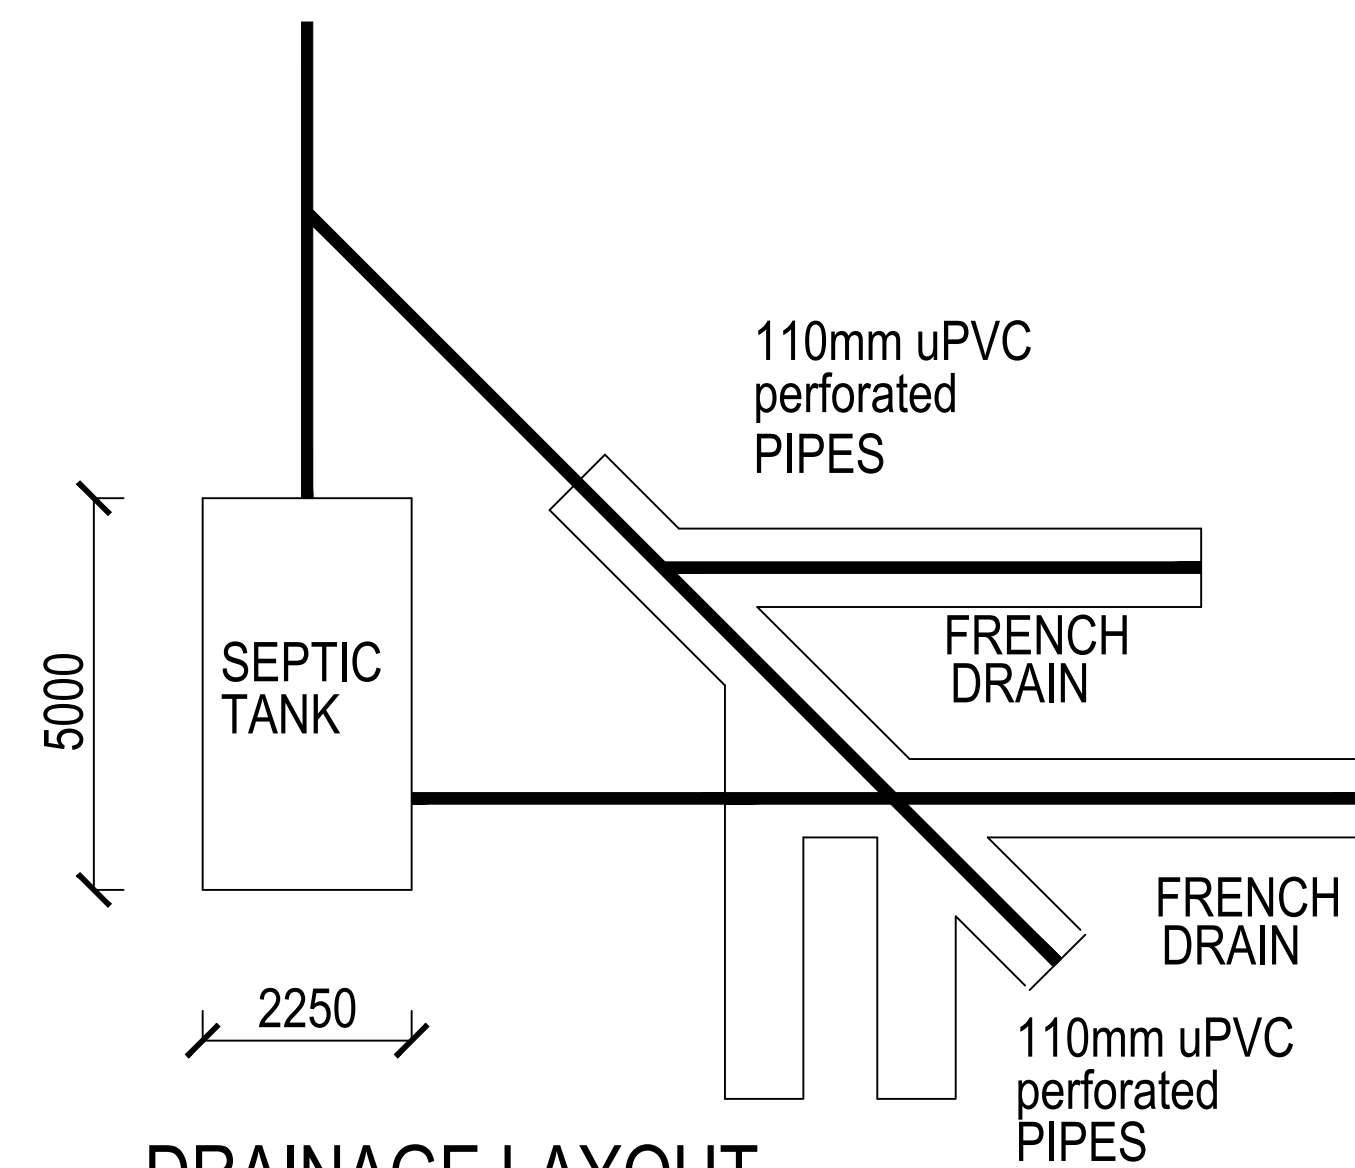

DRAINAGE LAYOUT

SEPTIC DETAILS AS PER
NNHBBC HOMEBUILDERS MANUAL

ROOF
406 KLIPLOK CHROMADEK SILICONE POLYESTER top coat finish
fixed to PURLINS with NL 65 CLIPS fixed to 114 x 38mm
S.A PINE PURLINS with two CADMIUM PLATED 3 no 10, 10
PURLINS with 24 x 16mm long self TAPPING screws
24 x 16mm long self TAPPING screws, as per APPROVED DESIGN
& SPECIALIST DESIGN COMPLETE WITH GUARANTEE ROOF TRUSSES
AND RAFTERS ANCHORED TO WALLS AND COLUMNS WITH GALVANISED
STEEL STRAPS OR WIRE BUILT INTO BRICKWORK MIN. DEPTH OF
80mm GLITTER DOWNPIPES AND WATERTANK PROVISIONAL

CEILING
4mm CLADIT A/C SHEETS FIXED TO UNDERSIDE OF
TRUSSES ONTO 38mm, 38mm BRANDERS AT MAX
SPACINGS OF 300x300mm, 75mm COVERED CORNICE

WALLS
BRICKWORK/BLOCKWORK (WHERE APPL) PLASTERED
OR BAGGED EXTERNALLY, PLASTERED AND PAINTED
INTERNALLY, BRICKFORCE - FOUNDATIONS EVERY
3rd LAYER, TOP STRUCTURE EVERY 5th LAYER
AND OVER WINDOWS & DOORS 3 LAYERS
WINDOW CILLS-INTERNAL, PLASTERED/EXTERNAL
PLASTERED SLOPING, DPC UNDER ALL CILLS
PRECAST LINTOLS OVER OPENINGS
PROVIDE 375 MICRON BRICK GRIP DPC.

FLOORS
25mm SCREED ON 75mm CONCRETE SURFACE
BED ON 250mm WATERPROOF SHEET ON WELL
COMPACTED FILL TREATED WITH 10 YEAR GUARANT.

FOUNDATIONS
650x230mm MASS CONCRETE STRIP FOOTING
TO EXTERNAL WALLS.
450x150mm DEEP THICKENING OF SURFACE
BED UNDER INTERNAL WALLS
ALL TREATED WITH 10YEAR GUARANTEE ANTIPROOF

ELECTRICAL LEGEND:

- 1.2m FLOURECENT LIGHT FIT
- 100W CEILING LIGHT
- 100W WALL mounted LIGHT
- 220V PLUG POINT
- PIANO TYPE LIGHT SWITCH
- DISTRIBUTION BOARD
- METER BOX

DRAINAGE:

- uPVC 110mm BARRON BOWL GRADE 304 STAINLESS
- w.c. MODEL NO.2 GRADE 304 STAINLESS STEEL
- h.c. MODEL NO.801 GRADE 304 STAINLESS STEEL
- i.e. INSPECTION EYE
- c.e. CLEANING EYE
- g. GULLY
- m.h. MANHOLE

				OPGEMEET DEUR / SURVEYED BY		ONTWERP DEUR / DESIGNED BY Mtema Mashoo Consulting Engineers (Pty) Ltd 15 Phindiso Street Tel: 015-307 7701 New Industrial Zone Fax: 015-307 7359 0850 info@mcemtemamashoo.co.za	ONTWERP DEUR DESIGNED BY MAKESSEN DEUR CHECKED BY	S.G.M. N.L.K. T.M.K. M.L.L.	ONTWERP GOEDGEEUR DESIGN APPROVED	GOEDGEEUR DEUR APPROVED BY	GREATER GIYANI MUNICIPALITY CONSTRUCTION OF NDHAMBHI TAXI RANK IN THE GREATER GIYANI MUNICIPALITY SEPTIC TANK	GREATER GIYANI MUNICIPALITY 	SKAAL / SCALE AS SHOWN	LEER N° / FILE N° - GOEDKEURINGS N° / AGREEMENT N°	DISTRIK / DISTRICT MOPANI DISTRICT PROJECT N° / PROJECT N° G/GMR104/008/2021	TYPE ONTWERP / TYPE OF DESIGN TAXI RANK PLAN N° / PLAN N° G/GMR104/008/2021/05
1	09/16	FOR APPROVAL														
Nr	DATUM	WYSIGINGS / AMENDMENTS	nr	HOOF V. DEPT.	DATUM											
No	DATE			BY HEAD OF DEPT.	DATE	HANDTEK / SIGNAT	DATUM / DATE									